



OWNERS:
Brian and Leensine Hoekstra
10040 E. Happy Valley Rd #2011
Scottsdale, AZ 85255

© Greg Klein Architect 2020

Revisions	Date
Conceptual Design Review	01-02-19
Schematic Design Review	02-07-19
Schematic Design Revision	02-16-19
Final Design Review	04-01-19
Monterey County Planning	04-30-19
Planning Res. 1	10-07-19
Building Permit Set	04-15-20

Hoekstra Residence
LOT E-24

92 Chamisal Pass
Carmel, CA 93923

APN: 239-002-007

Drawing Title

Senior Unit and Garage
Floor Plans


Scale 1/4"=1'-0"

Drawn By


Job Number 2018-08

Drawing Number

A204

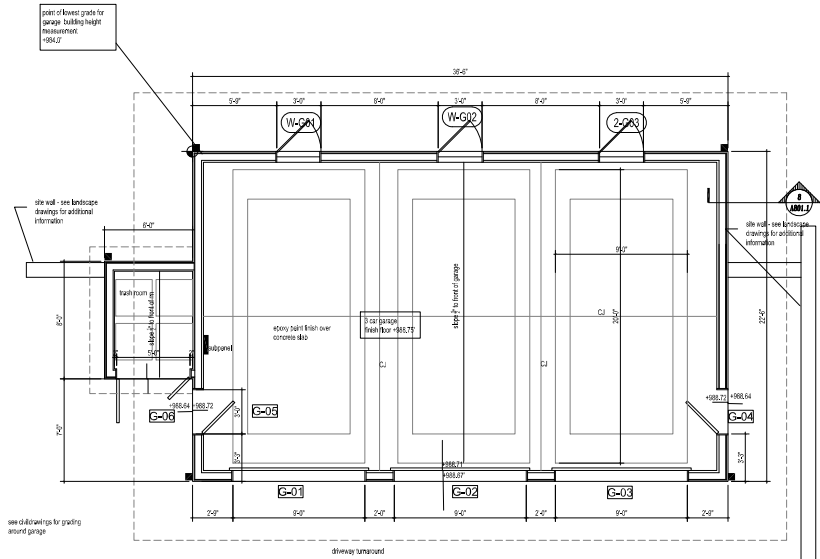

GARAGE FLOOR PLAN

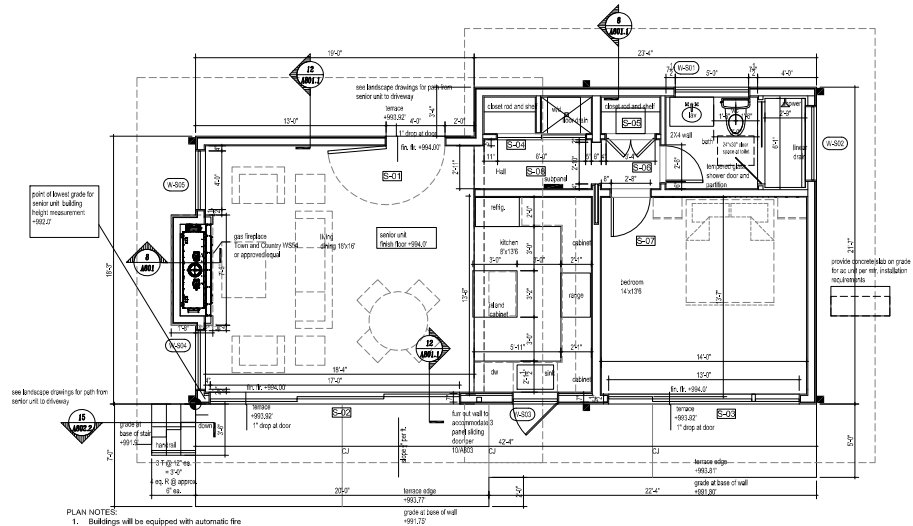

SENIOR UNIT FLOOR PLAN

SEE A201 FOR FLOOR PLAN NOTES

- PLAN NOTES:
- Buildings will be equipped with automatic fire sprinkler system per NFPA 13R.
 - See SCHEDULES for electrical and mechanical plans and requirements.